


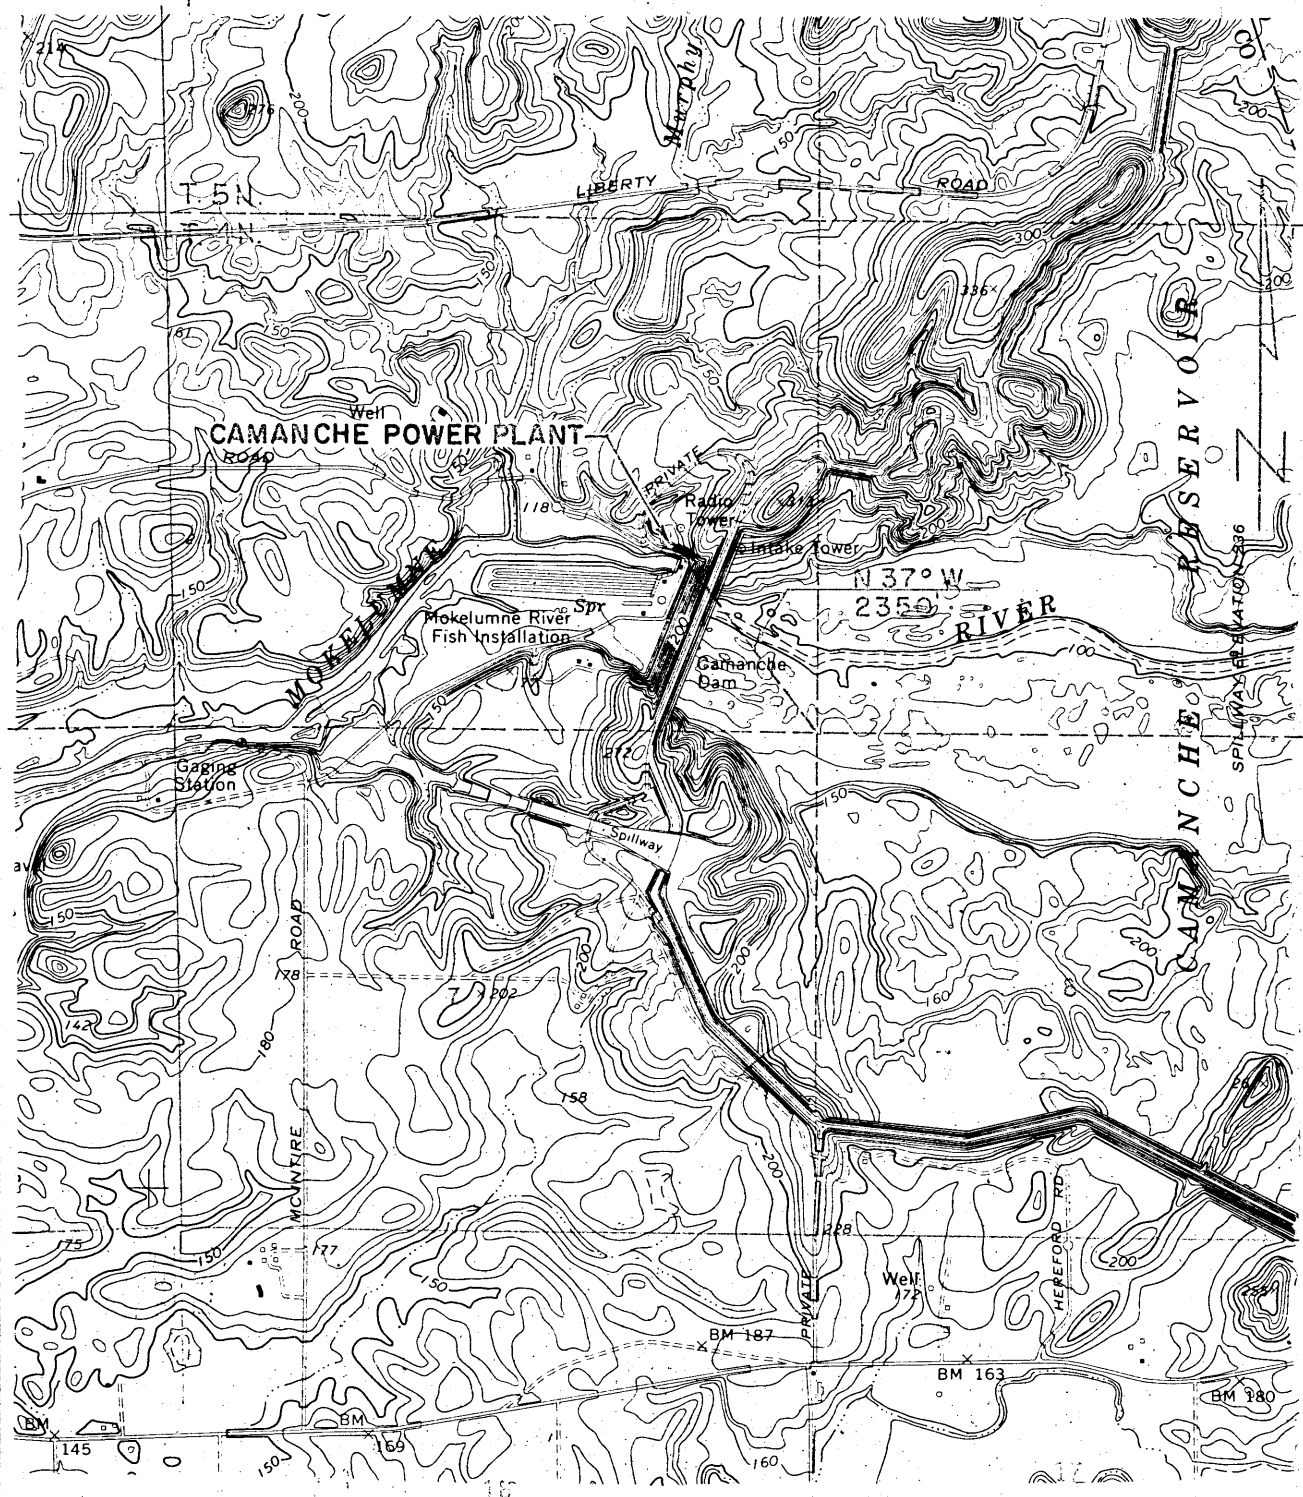

CERTIFICATE OF ENGINEER
I, DONALD G. LARKIN, OF 2150 ADELPHI STREET, OAKLAND, CALIFORNIA, DO HEREBY CERTIFY THAT THIS MAP WAS PREPARED UNDER MY DIRECTION FROM A U.S. GEOLOGICAL SURVEY 7.5 MINUTE CLEMENTS TOPOGRAPHIC QUADRANGLE AND THAT IT CORRECTLY REPRESENTS THE LOCATION OF THE PROPOSED WORKS DESCRIBED IN THE ACCOMPANYING APPLICATION.

DONALD G. LARKIN *Donald G. Larkin*
ENGINEER CERTIFICATE NO. C7624

APPROVED *W. L. Larkin*

ASST. GEN. MGR. & CHIEF ENGINEER, EAST BAY M.U.D.

EAST BAY MUNICIPAL UTILITY DISTRICT
OAKLAND, CALIFORNIA

LOCATION MAP CAMANCHE POWER PLANT

DESIGNED BY	TRACED BY
DRAWN BY OTHERS	SCALE 1:24000
CHECKED BY	DATE 8-17-35
RECOMMENDED BY <i>W. L. Larkin</i>	APPROVED BY <i>W. L. Larkin</i>
No. 1935-A	